



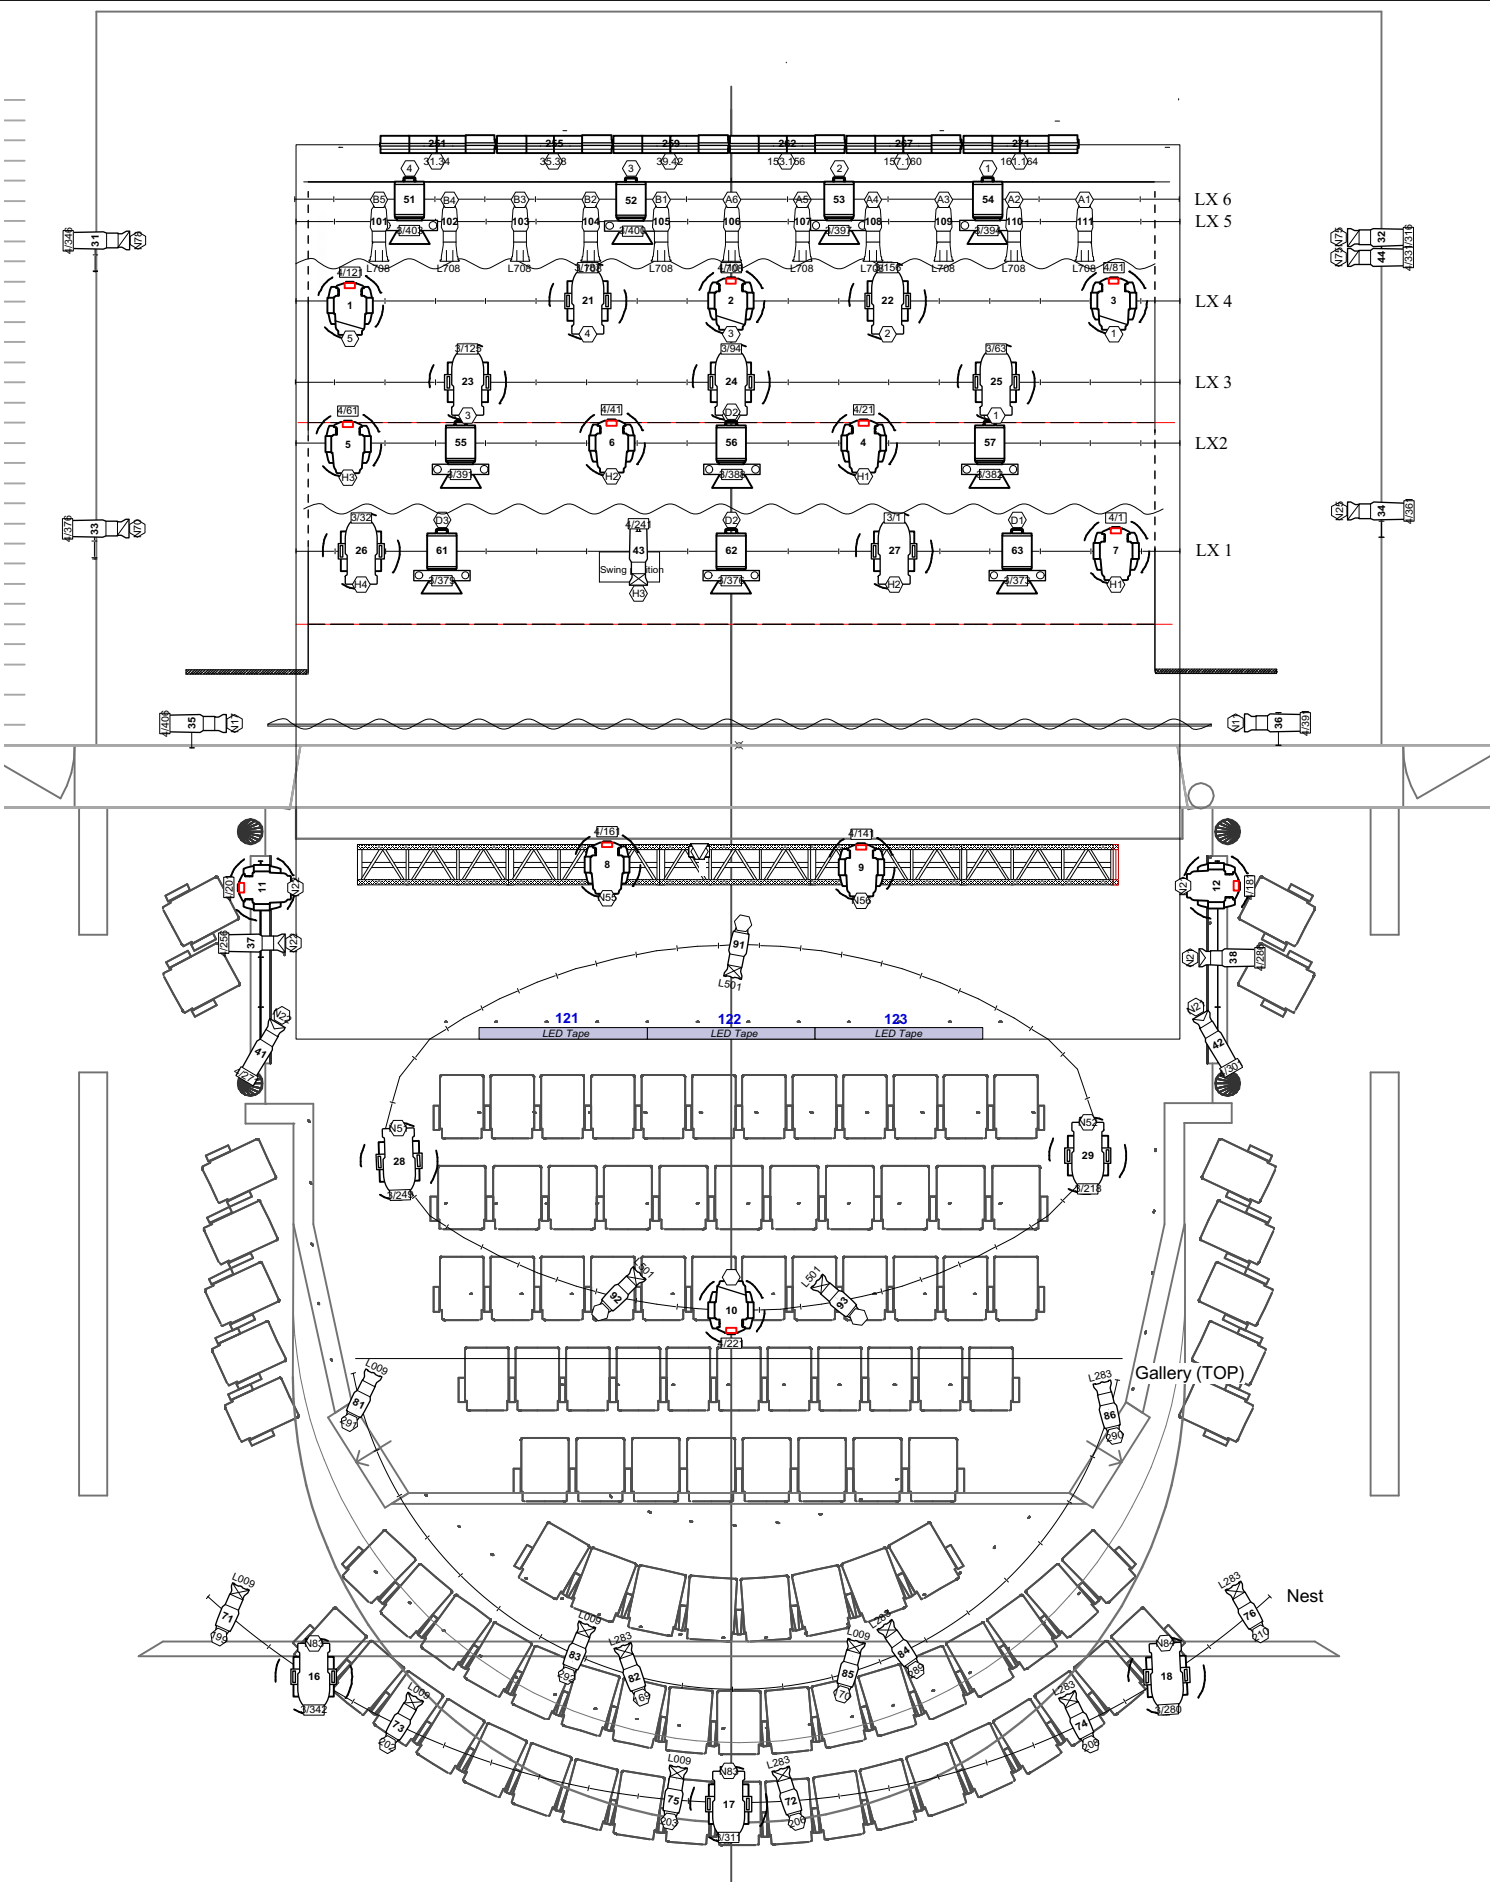

- ETC Source4 14deg
- ETC CE Source4 19deg
- ETC CE Source4 26deg
- ETC CE Source4 36deg
- ADB Lighting F201
- Selecon LUI CYC 4

- ETC Source4 LED2LS 19deg
- ETC Source4 LED 26deg
- ETC Source4 LED 36deg
- ETC Source4 LED 50deg

- ETC Revolution
- Martin MAC TW1
- Martin MAC TW1 Narrow

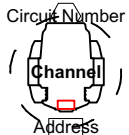

Lighting Plan V4.5

Date: 24/01/20

Scale: 1:75 @ A3

Earthquakes in London

Milton Court Theatre
February 2020



Earthquakes in London